



- A Moduform ceiling mounted recessed indirect luminaire
- B Solstar 220mm dia recessed low energy compact fluorescent downlight
- C Solstar 220mm dia recessed low energy compact fluorescent downlight with frosted halo glass attachment
- E axent SZN 190 x 370mm compact fluorescent wall mount light fitting
- F DLI 130mm LED recessed downlight
- G Varisty range IP40 surface luminaire


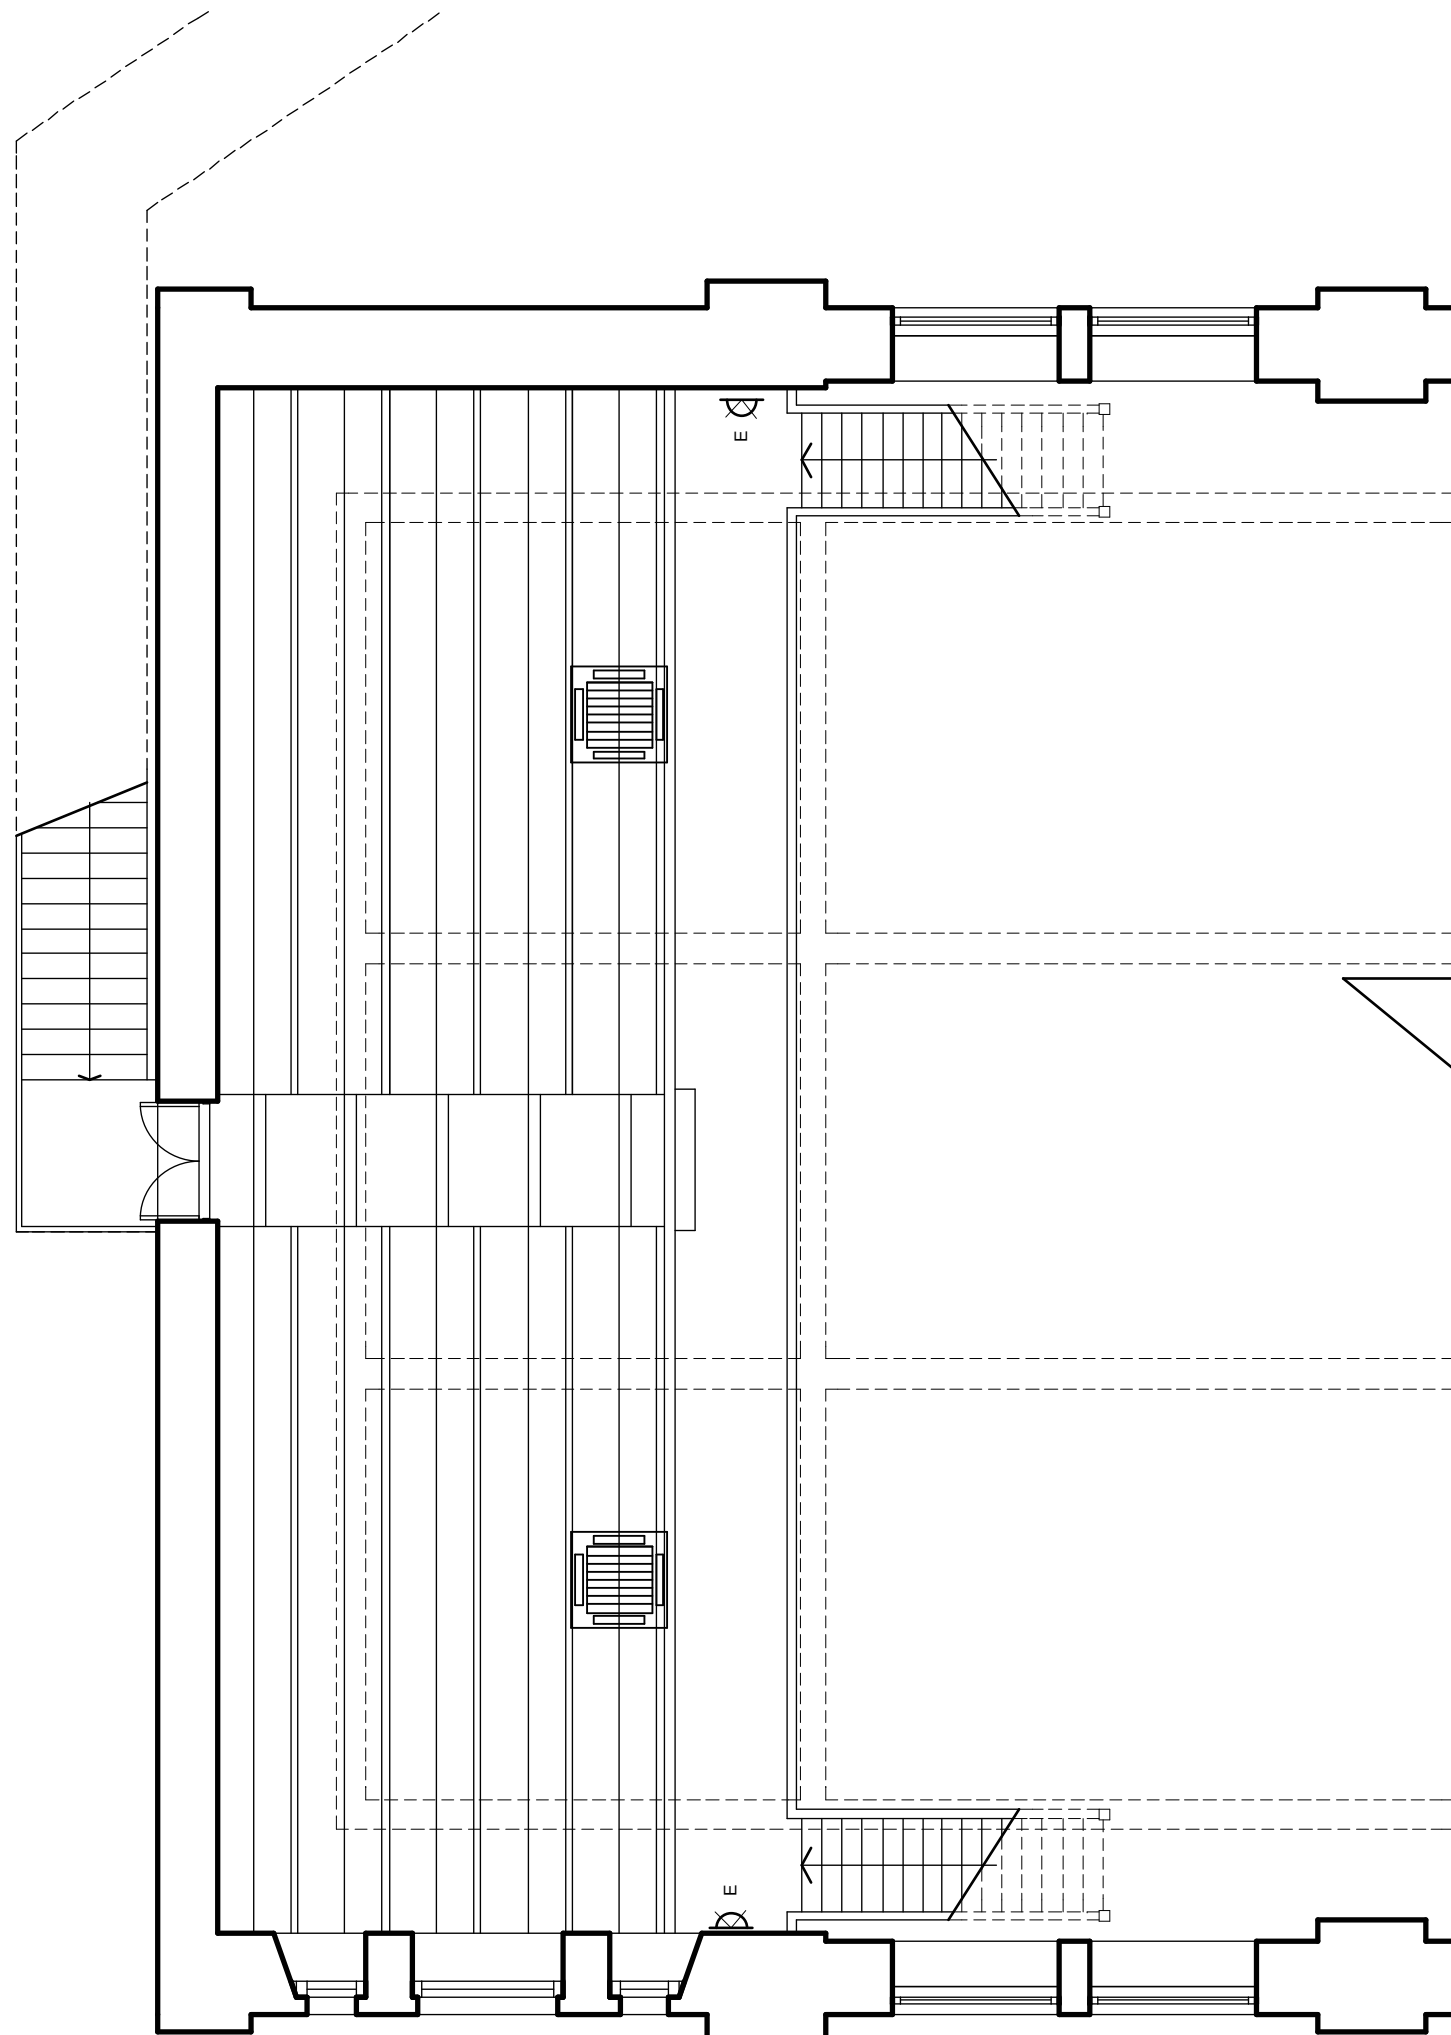


balcony floor plan

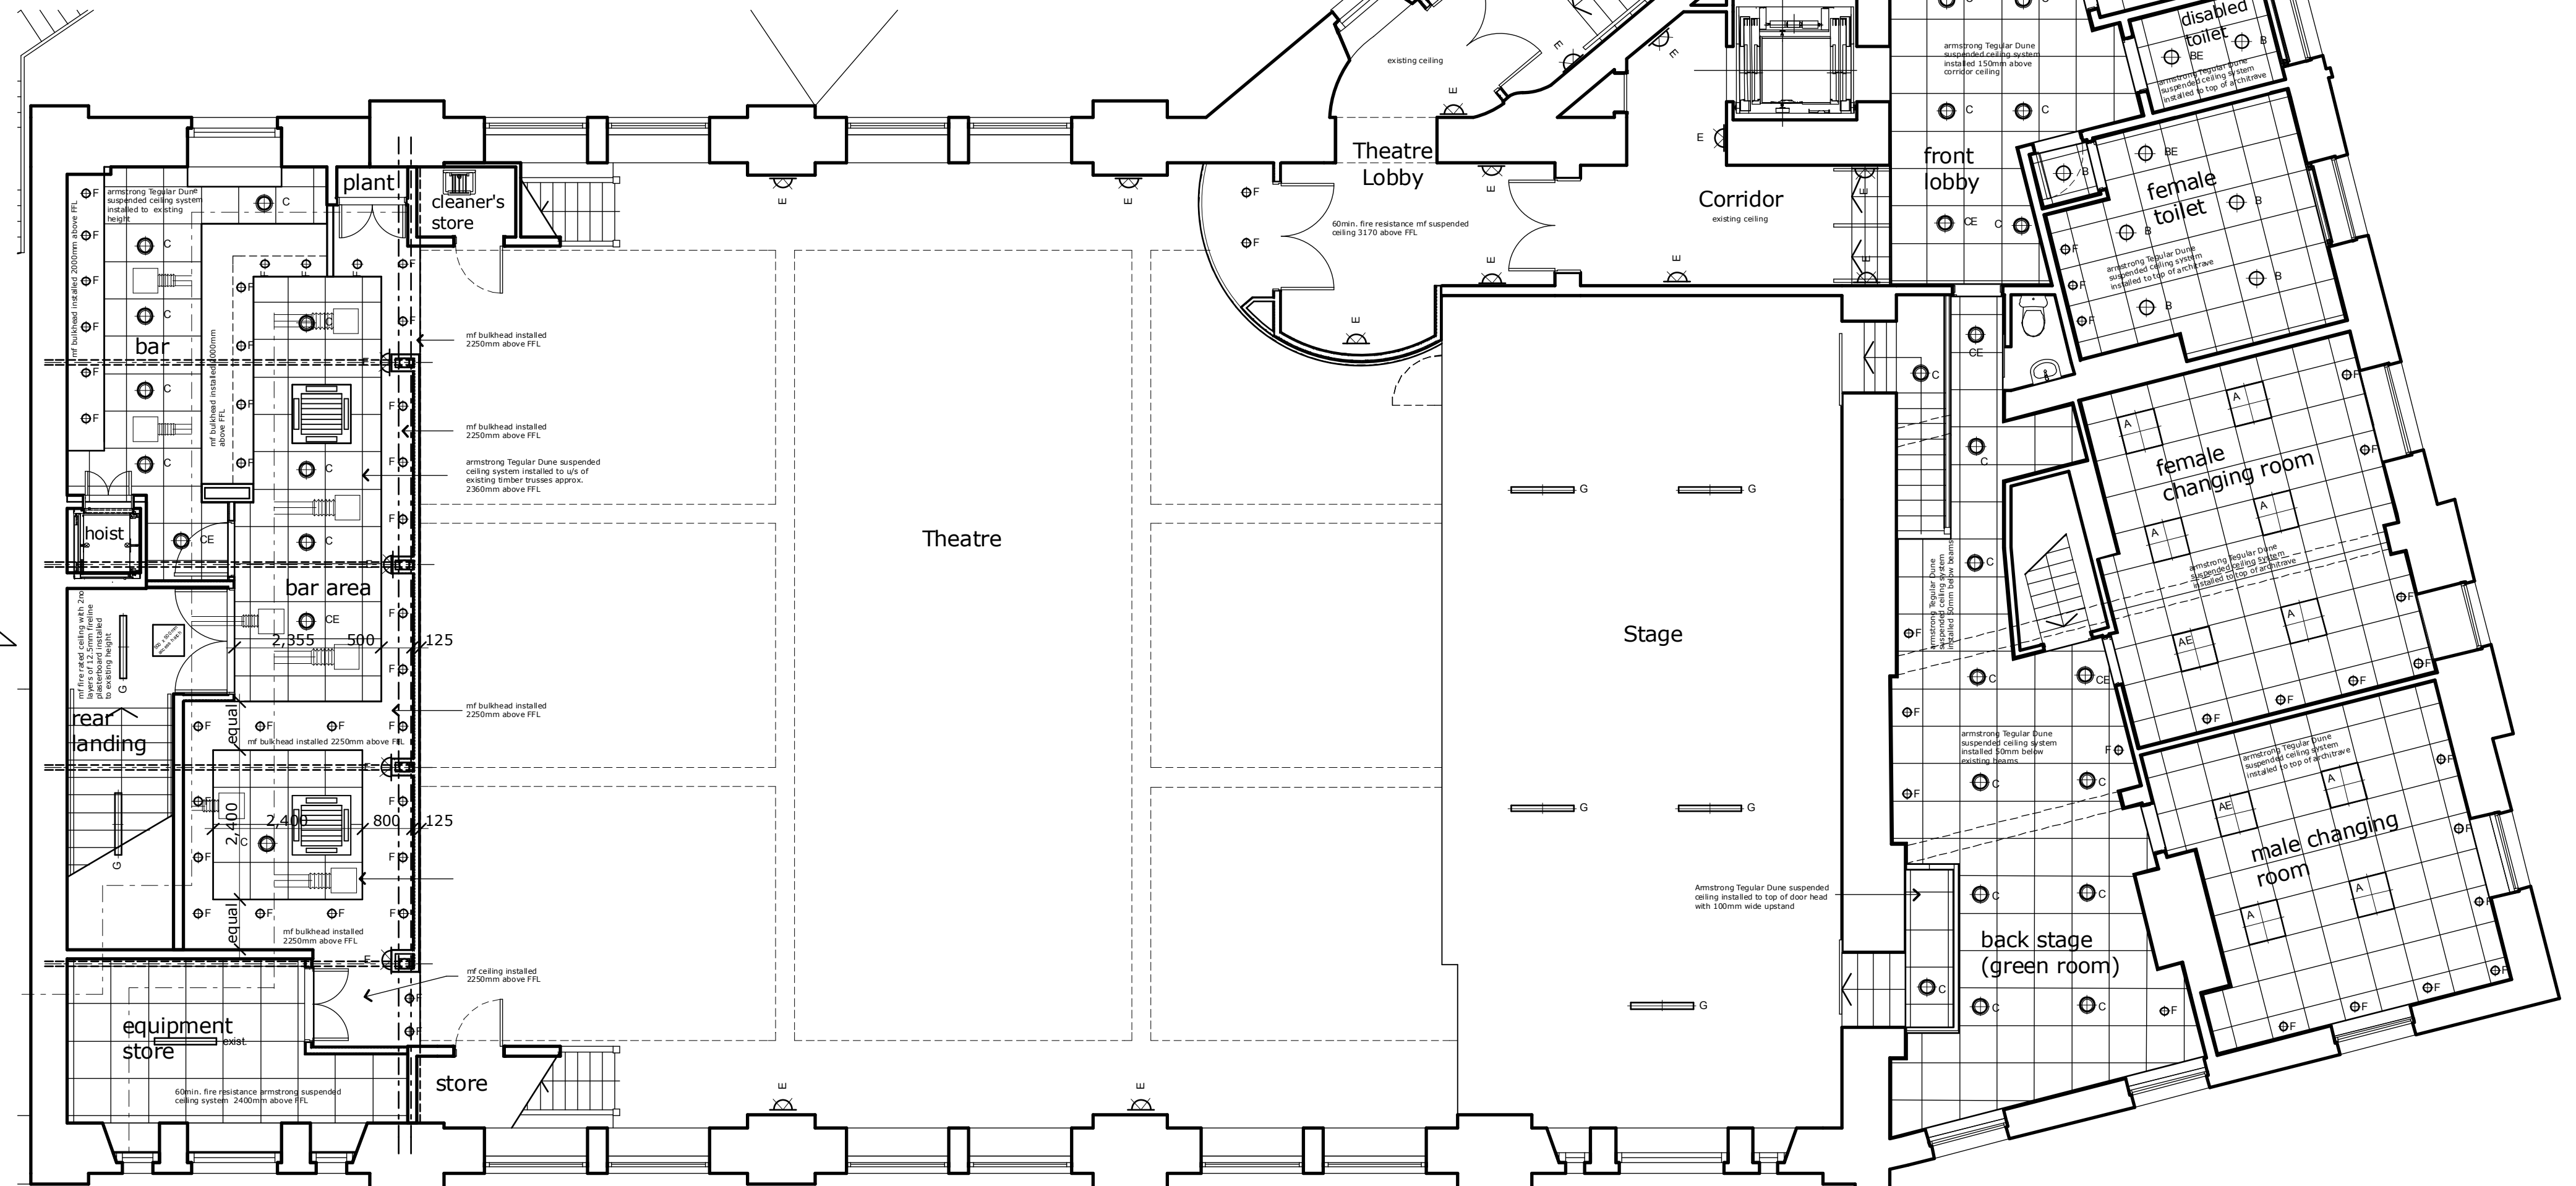

first floor plan

- revisions:
- Rev. A - 22.09.10/sc - bar area, theatre lobby, lighting layout revised; balcony floor plan, ceiling mounted AC units added
- Rev. B - 04.10.10/sc - ceiling and lighting layout revised to all areas; type D light fitting removed
- Rev. C - 14.10.10/sc - ceiling and lighting layout revised in bar area and backstage
- Rev. D - 19.10.10/sc - ceiling and lighting layout revised in bar area
- Rev. E - 03.11.10/sc - ceiling and lighting layout revised in bar area; ventilation added
- Rev. F - 11.03.11/sc - ceiling layout revised in equipment store; lighting layout revised in bar seating area and backstage

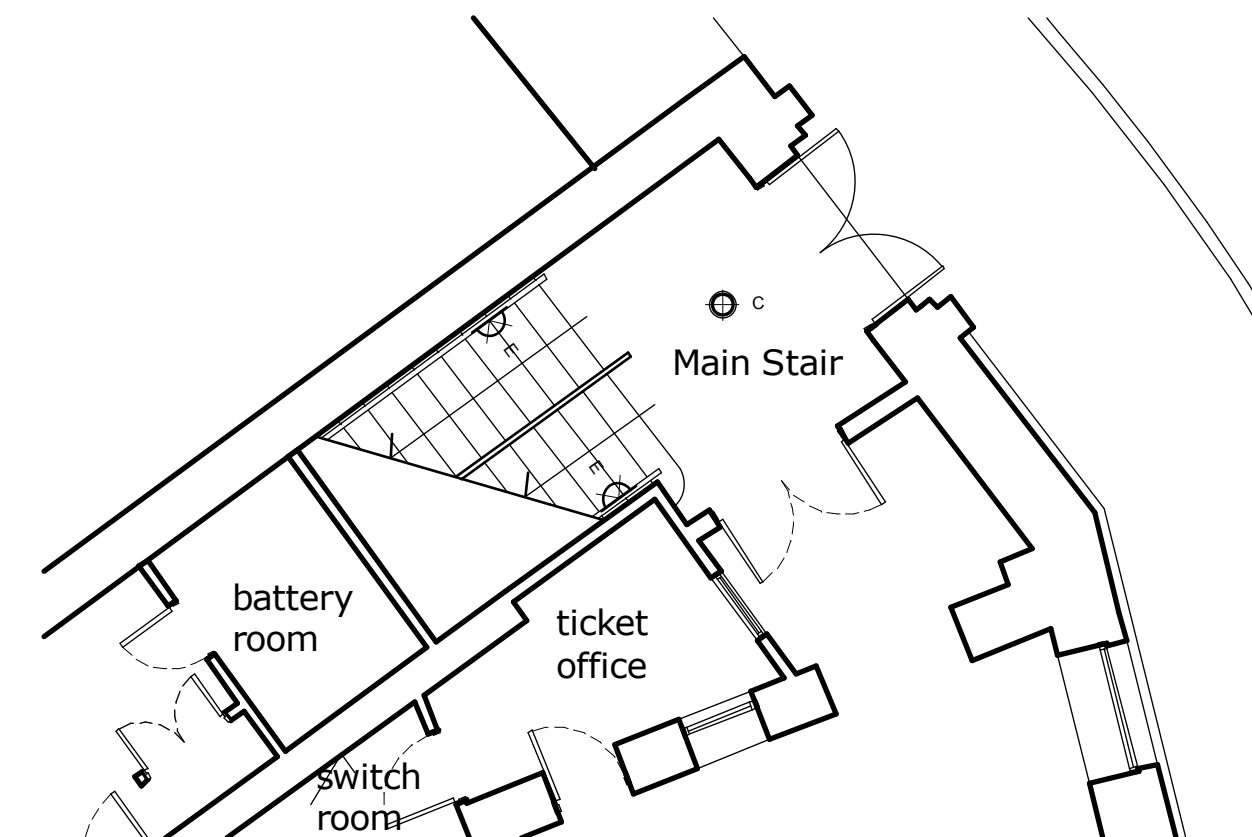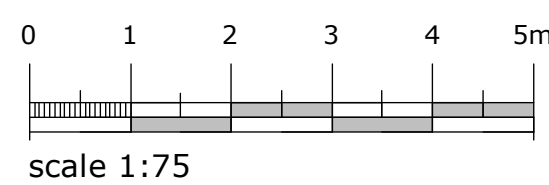

part ground floor plan

AS BUILT

campbell driverpartnership
architects designers surveyors

client: hyndburn borough council

project: oswaldtwistle civic theatre
union road accrington

sheet: proposed ceiling and lighting layout

dwg no:	09.138	21	F
---------	--------	----	---

scale: 1:75 @ A1
date: 23.08.10
drawn: SC
capricorn park
blackwater road
blackburn bb1 5qr
t: 01254 297700
f: 01254 297701
email: design@cdparchitects.co.uk

copyright in this drawing is vested in campbell driver partnership limited