

THIS DRAWING IS INDICATIVE AND REPRESENTS ONLY THE DESIGN INTENT, THE CONTRACTOR MUST PRODUCE FULLY CO-ORDINATED WORKING / INSTALLATION DRAWINGS AS REFERRED TO IN THE CONTRACT DOCUMENTATION

SECURITY SCHEMATIC NOTES

- DO NOT SCALE FROM THIS DRAWING.
- ALL ELECTRICAL WORKS SHALL COMPLY WITH THE 18TH EDITION IET WIRING REGULATIONS (BS 7671:2018) INCLUDING ALL CURRENT AMENDMENTS AND GUIDANCE NOTES, AND THE CURRENT BUILDING STANDARDS (ENGLAND) REGULATIONS.
- THESE DRAWINGS NOTE THE DESIGN INTENT OF THE NEW SECURITY INTERCOM AND ACCESS CONTROL INSTALLATIONS ONLY. THE FINAL DESIGN OF THE SYSTEM SHALL BE CARRIED OUT BY NSI GOLD CERTIFIED CONTRACTOR.
- THE SPECIALIST DESIGN CONTRACTOR SHALL PROVIDE THE NECESSARY CERTIFICATION FOR THE DESIGN, INSTALLATION AND COMMISSIONING OF THE NEW SECURITY ALARM SYSTEM.
- ALL SECURITY SYSTEMS TO BE FULLY TESTED AND COMMISSIONED UPON COMPLETION OF WORKS PRIOR TO HANDOVER.
- PLEASE READ IN CONJUNCTION WITH THE SECURITY LAYOUTS.

P04	DRAFT TENDER ISSUE	TG	JR	A3	29.10.25
P03	STAGE 4B UPDATE	JG	JR	A3	18.07.25
P02	STAGE 4B ISSUE	JG	JR	A3	13.06.25
P01	STAGE 4A ISSUE	JG	JR	A3	04.04.25
REV	DESCRIPTION	BY	CHK	APP	DATE

Project Status: DRAFT TENDER ISSUE

h

HARLEY HADDOW


ENGINEERING POWERED BY THE PAST
BUILDING THE FUTURE

Unit A2, Hatchers Yard
9 Tanner Street
London, SE1 3LE
T 44 (0) 203 755 9360
www.harleyhaddow.com

Project: 313293
TOWER OF LONDON
REVELLER

Drawing Title:
ACCESS CONTROL SCHEMATIC

Scale @ A1 NTS	Date APR 2025	Engineer JR
Drawing No. 313293-HAH-XX-XX-D-E-06890	Revision P04	

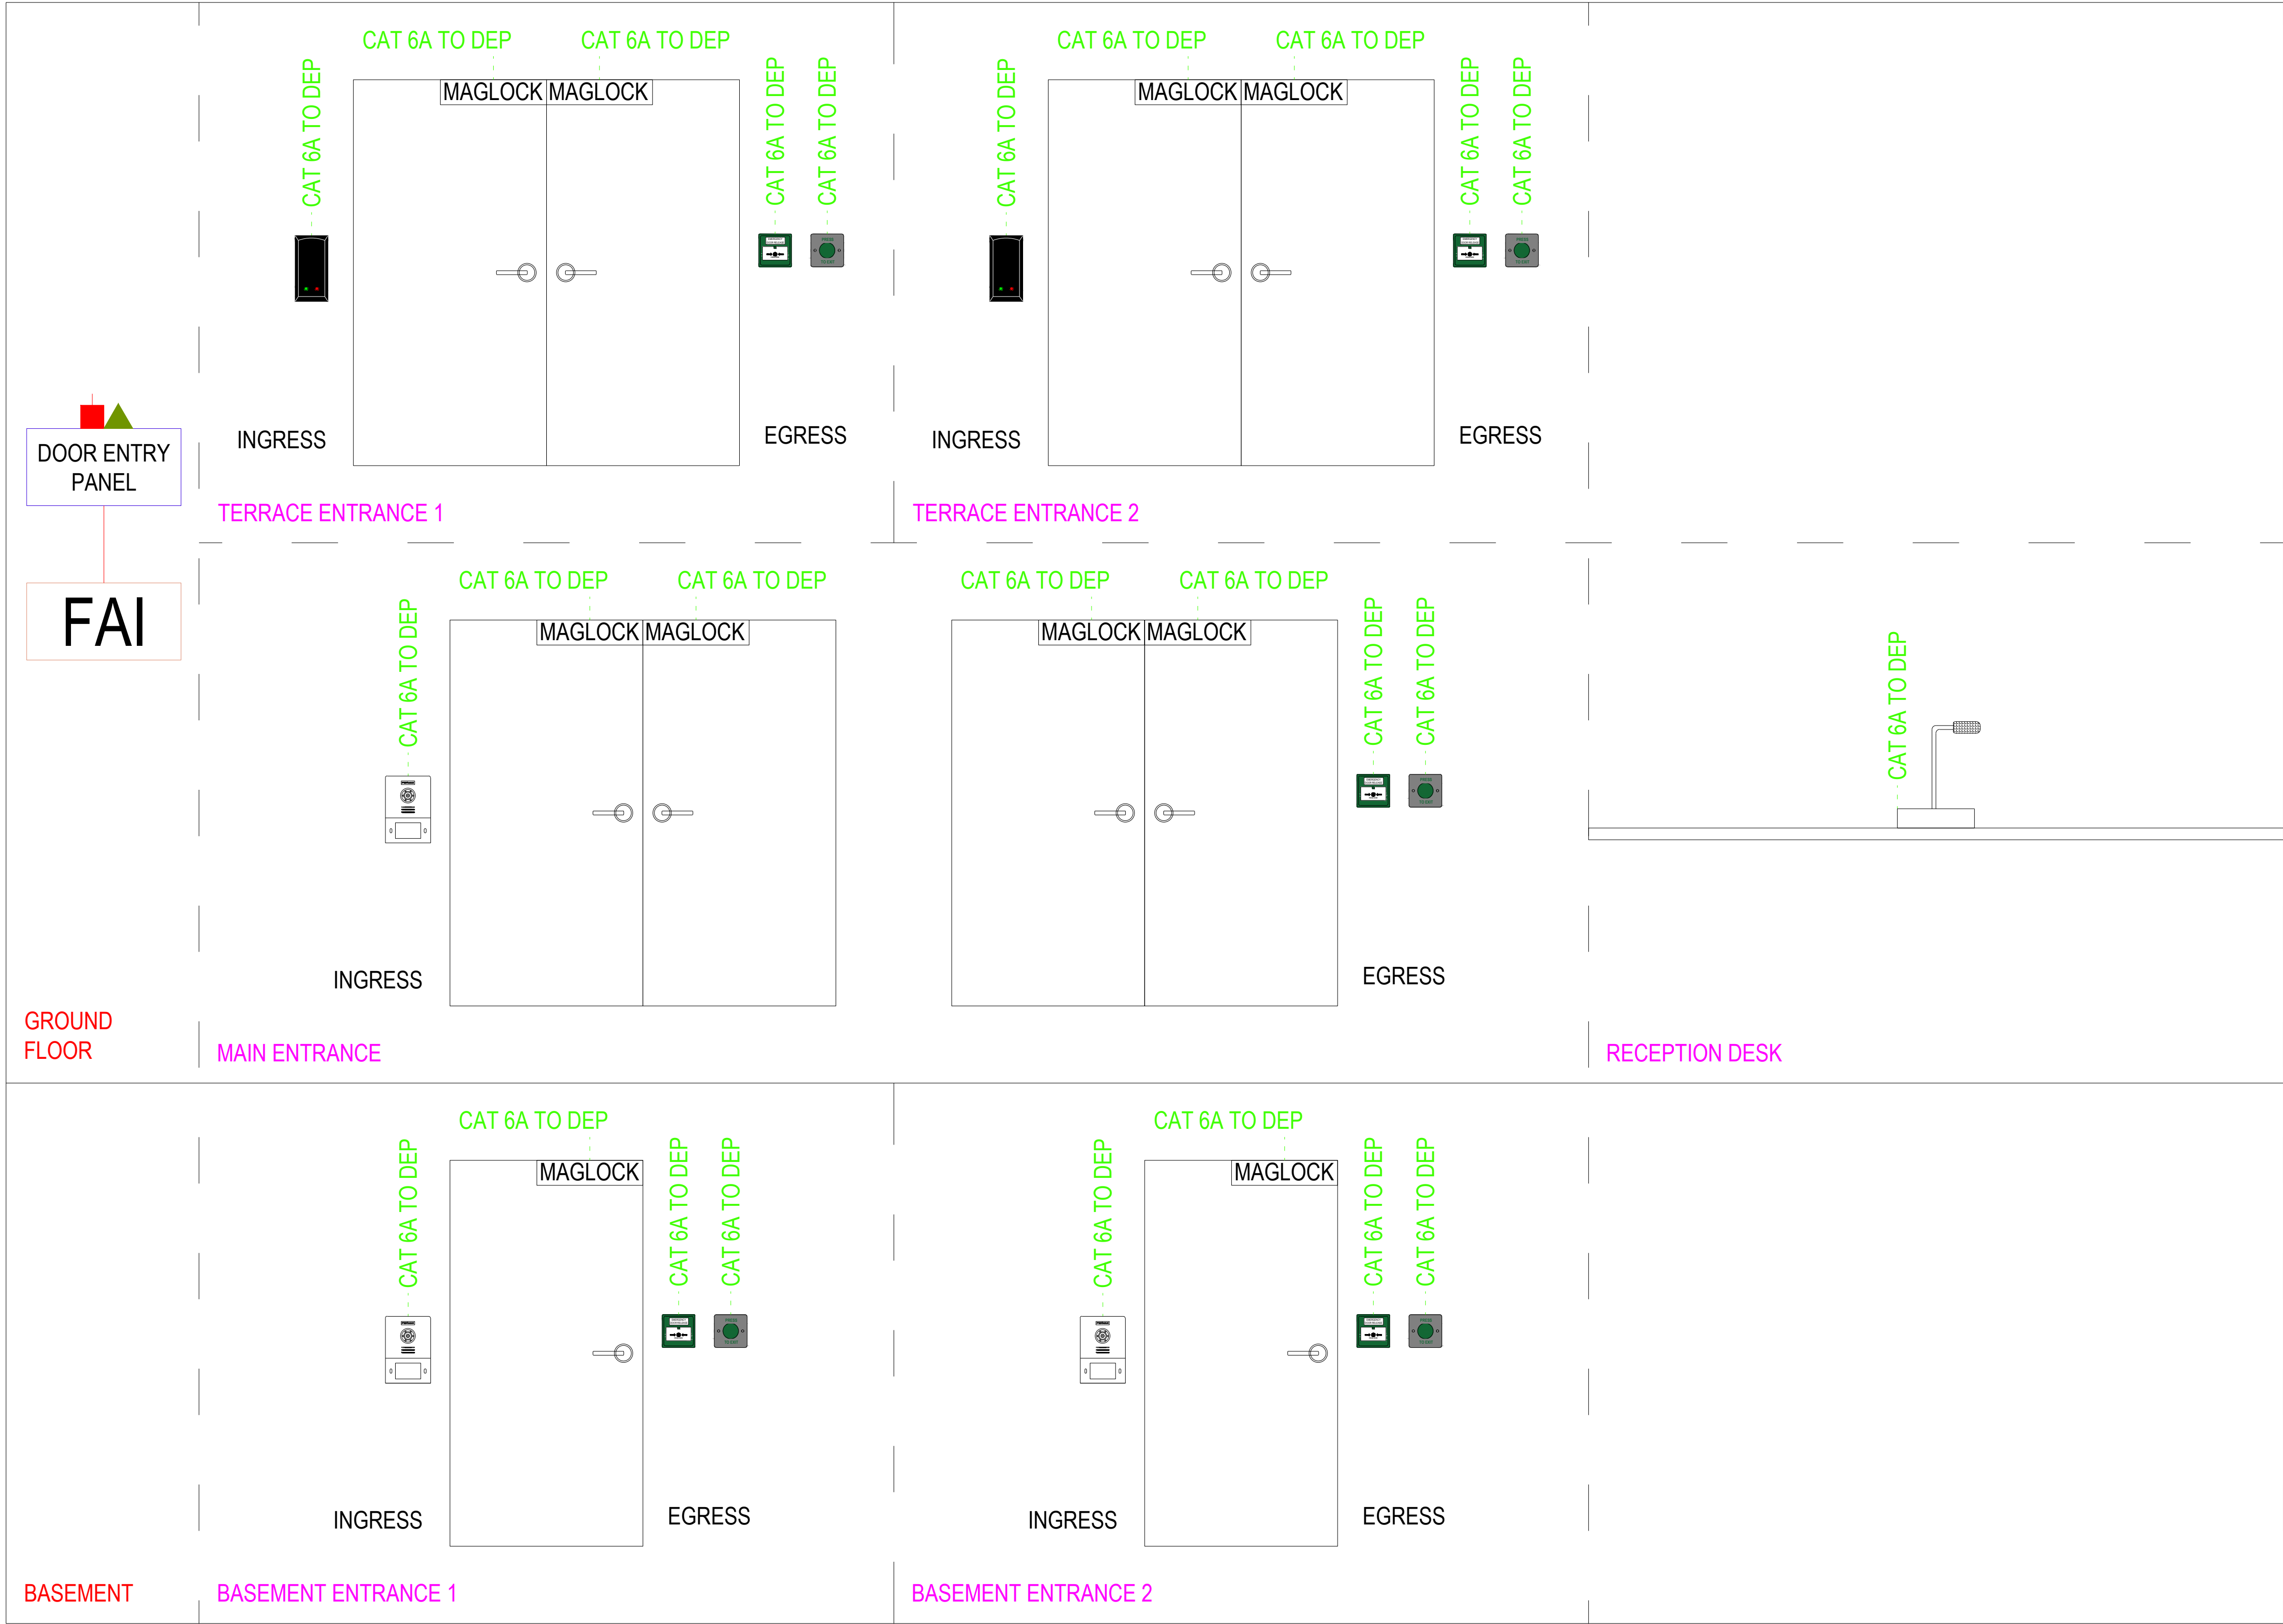

SCHEMATIC REPRESENTATION

DRAWING REPRESENTATION

TITLE

DOOR ENTRY
INTERCOM

CARD READER

BREAK GLASS

PUSH TO EXIT

INTERCOM

MAGLOCK

UNSWITCHED
SPUR

RJ45 OUTLET

FIRE ALARM
INTERFACE

DOOR ENTRY
PANEL