

ALL GREYED ITEMS ARE OUTSIDE THE SCOPE OF THIS DRAWING

THIS DRAWING IS INDICATIVE AND REPRESENTS ONLY THE DESIGN INTENT, THE CONTRACTOR MUST PRODUCE FULLY CO-ORDINATED WORKING / INSTALLATION DRAWINGS AS REFERRED TO IN THE CONTRACT DOCUMENTATION

NOTES

- DO NOT SCALE FROM THIS DRAWING. ALL DIMENSIONS INDICATED ARE IN MILLIMETRES.
- THIS IS NOT A CONSTRUCTION DRAWING.
- DRAWING TO BE READ IN CONJUNCTION WITH SPECIFICATION, DOCUMENTATION, DRAWINGS & ALL RELEVANT BRITISH STANDARD DOCUMENTS
- AUDIO VISUAL ITEMS INDICATED ARE PRELIMINARY ONLY. THE FULL AV DESIGN IS TO BE COMPLETED BY THE SPECIALIST.
- SECURITY ITEMS INDICATED ARE PRELIMINARY ONLY. THE FULL SECURITY DESIGN IS TO BE COMPLETED BY THE SPECIALIST.
- ACCESS CONTROL ITEMS INDICATED ARE PRELIMINARY ONLY. THE FULL SECURITY DESIGN IS TO BE COMPLETED BY THE SPECIALIST.
- IT/DATA ITEMS INDICATED ARE PRELIMINARY ONLY. THE FULL IT/DATA DESIGN IS TO BE COMPLETED BY THE SPECIALIST.
- CHUBB SECURITY ARE TO REVIEW AND COMMENT ON SECURITY ARRANGEMENTS.
- JFA TO ADVISE ON LIGHTING ARRANGEMENT.
- 3 HOUR EMERGENCY LIGHTING BACK UP PACKS TO BE INSTALLED AS REQUIRED IN ACCORDANCE WITH BS 5266-1.
- SYSTEM DESIGNED TO L1 P1 STANDARD AS DEFINED IN BS 5839-1.
- TFS TO REVIEW SMOKE DETECTION AND ALARM REQUIREMENTS.
- TFS RESPONSIBLE FOR COMMISSIONING OF THE FIRE ALARM SYSTEM.

- LEGEND**
- DAC** DISABLED ALARM CONTROL PANEL
  - RSU** RESET BUTTON
  - ODL** OVERHEAD DOOR LIGHT
  - DISABLED PULL CORD
  - S** SMOKE DETECTOR
  - SX** SMOKE DETECTOR C/W BEACON AND SOUNDER
  - FR** FOB READER
  - PB** PUSH BUTTON TO EXIT
  - BE** EMERGENCY DOOR RELEASE
  - ML** MAG LOCK
  - WL** WIRELESS LOCK
  - WIFI** WIFI POINT
  - 2** DOUBLE SOCKET OUTLET
  - 2 USB** DOUBLE DUAL USB SOCKET OUTLET
  - 2** DOUBLE RJ45 OUTLET
  - ABSENCE/PRESENCE DETECTOR
  - LIGHT SWITCH
  - FUSED CONNECTION UNIT
  - LCP** LIGHTING CONTROL PANEL

REV	DESCRIPTION	BY	CHK	APP	DATE
P06	DRAFT TENDER ISSUE	TG	JR	AJ	29.10.25
P05	STAGE 4B UPDATE	TG	JR	AJ	18.07.25
P04	STAGE 4B ISSUE	TG	JR	AJ	13.06.25
P03	STAGE 4A ISSUE	JG	JR	AJ	04.04.25
P02	STAGE 3 ISSUE	JG	JR	AJ	25.11.24
P01	STAGE 3 COORDINATION ISSUE	JG	JR	AJ	08.11.24


Project Status: **DRAFT TENDER ISSUE**



Project: 313293  
**TOWER OF LONDON  
REVELLER**

Drawing Title:  
**THE ARCHES  
ELECTRICAL SERVICES**

Scale @ A1	Date	Engineer
1:50	JULY 2024	JG/JR
Drawing No.	Revision	
313293-HAH-01-XX-D-E-06054	P06	

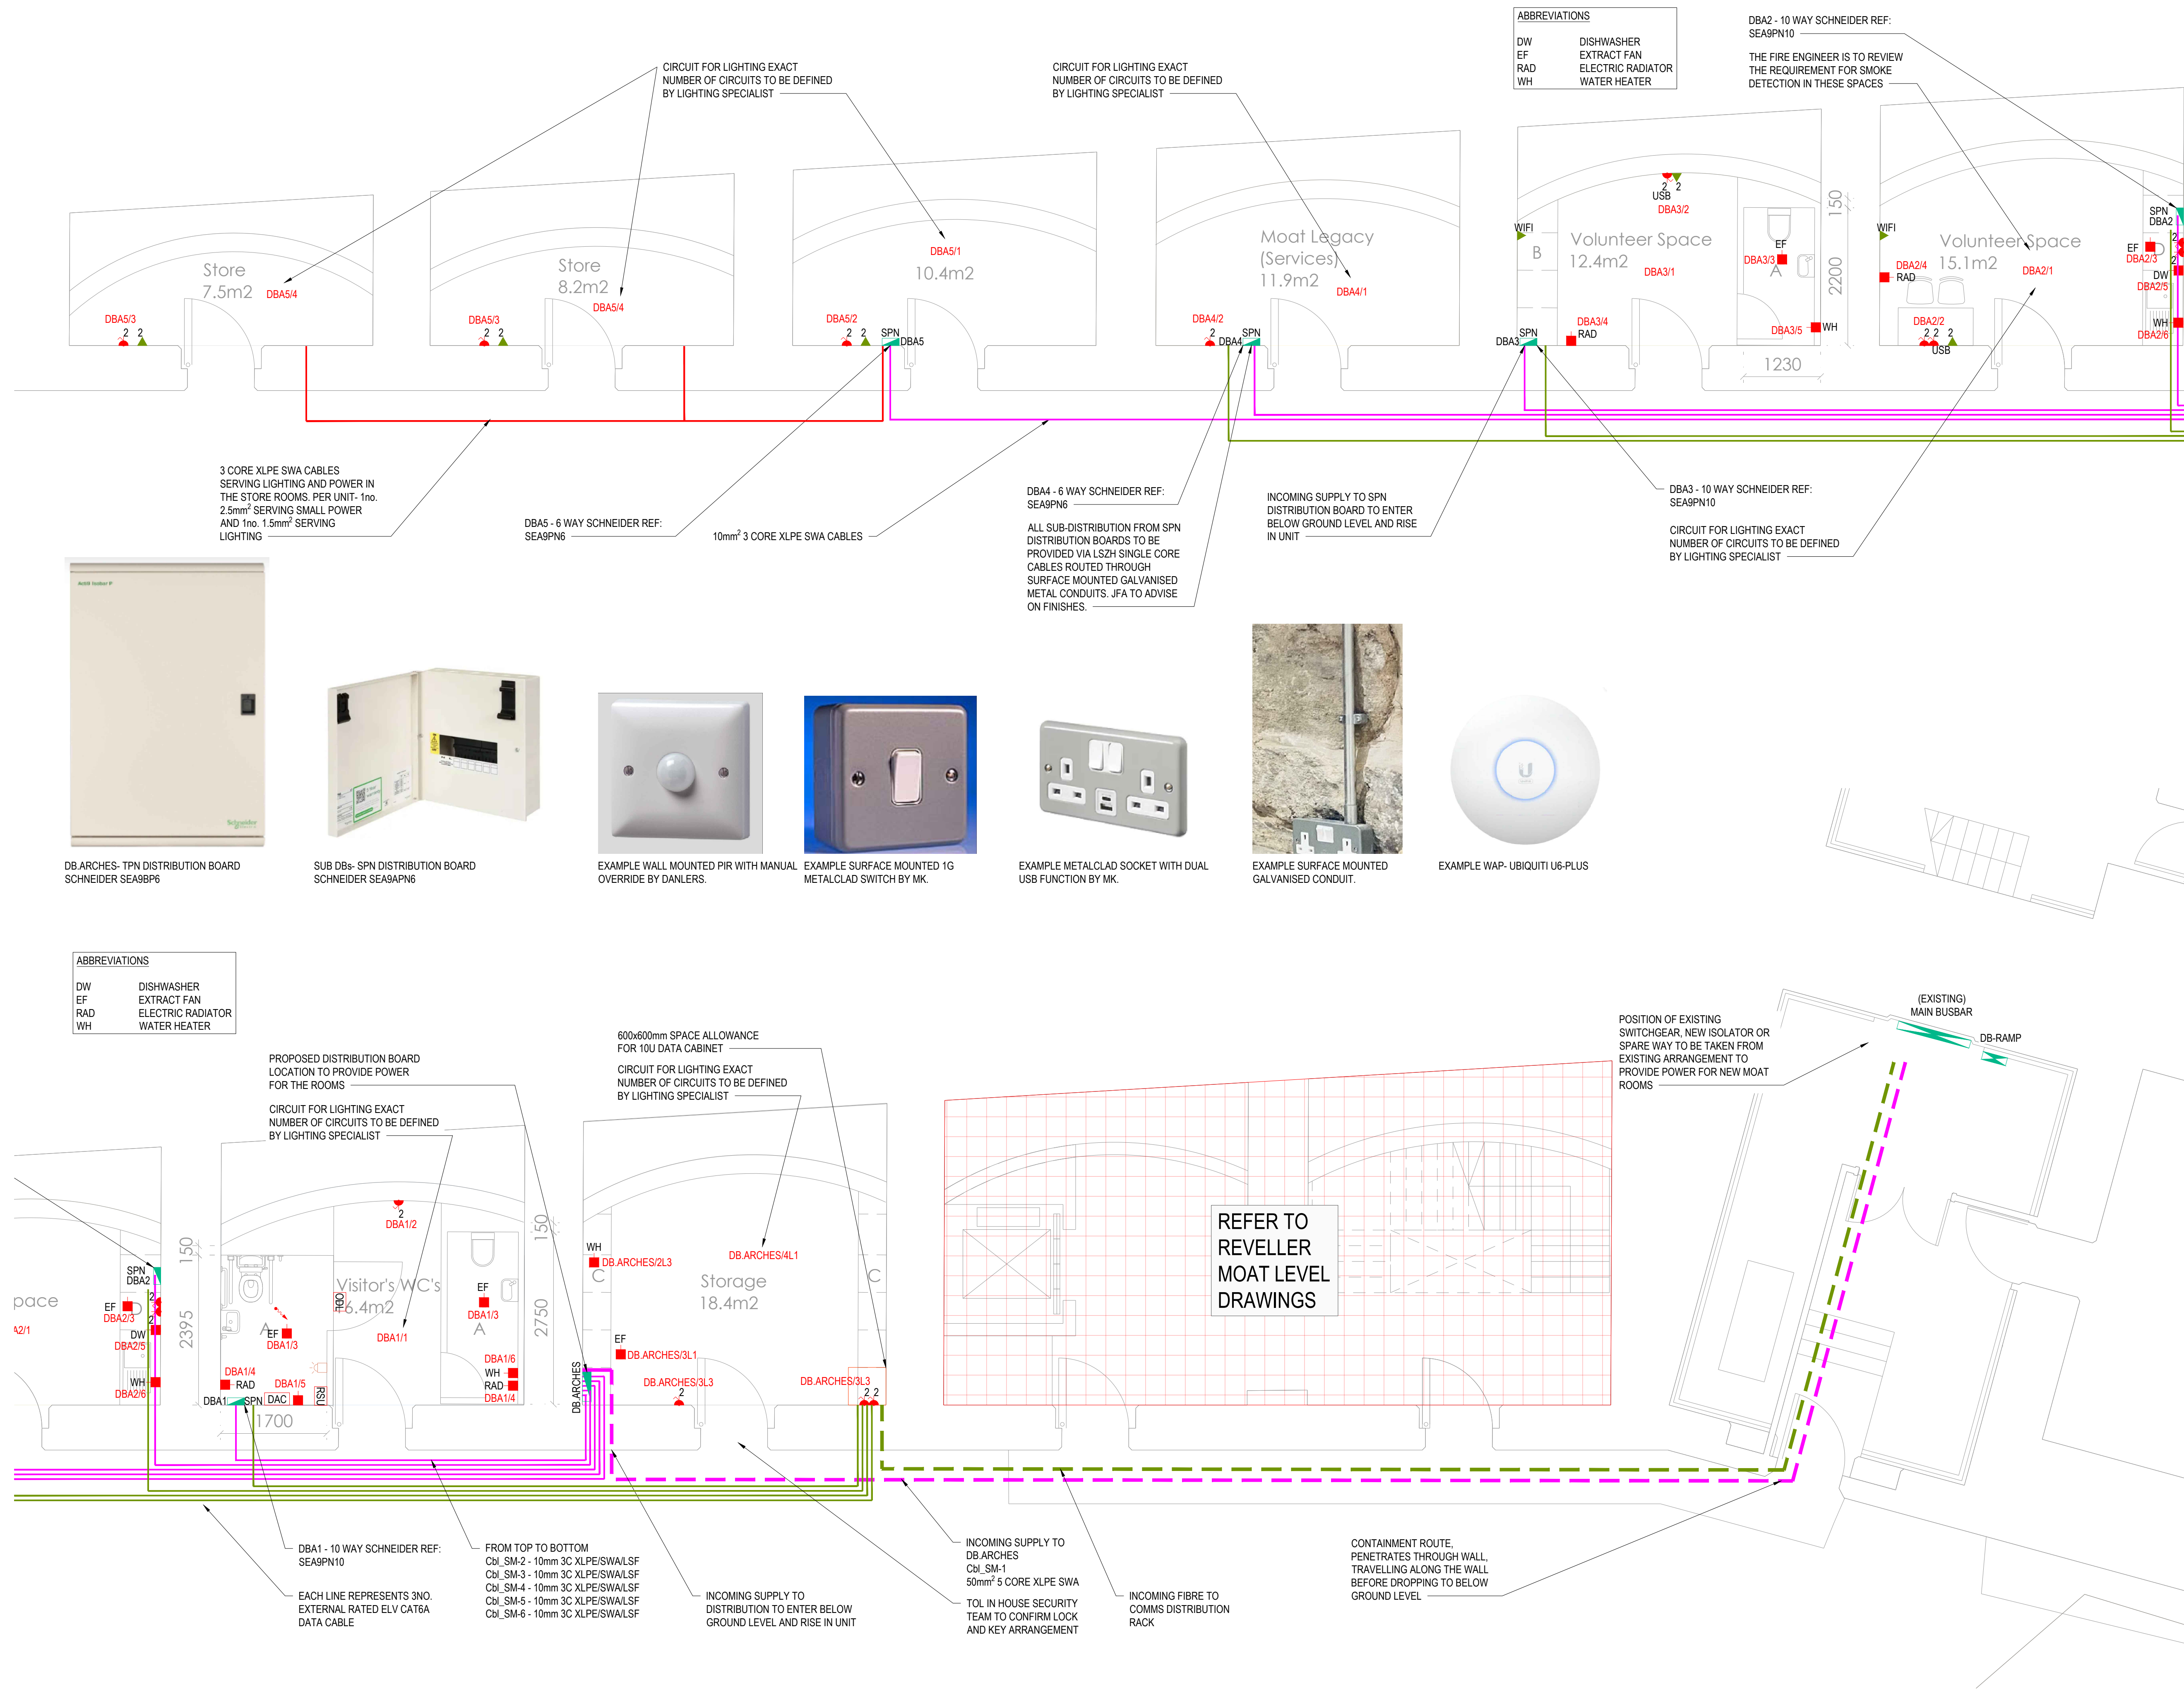

FILENAME: Z:\PROJECTS\313293 - TOL - REVELLER\PROJECT\07\HAH DRAWINGS\02 CAD\02 ELECTRICAL\313293-HAH-01-XX-D-E-06054.DWG | PLOTTED DATE: 29 October 2025 09:35:59