



THIS DRAWING IS INDICATIVE AND REPRESENTS ONLY THE DESIGN INTENT, THE CONTRACTOR MUST PRODUCE FULLY CO-ORDINATED WORKING / INSTALLATION DRAWINGS AS REFERRED TO IN THE CONTRACT DOCUMENTATION

SECURITY SCHEMATIC NOTES


- DO NOT SCALE FROM THIS DRAWING.
- ALL ELECTRICAL WORKS SHALL COMPLY WITH THE 18TH EDITION IET WIRING REGULATIONS (BS 7671:2018) INCLUDING ALL CURRENT AMENDMENTS AND GUIDANCE NOTES, AND THE CURRENT BUILDING STANDARDS (ENGLAND) REGULATIONS.
- THESE DRAWINGS NOTE THE DESIGN INTENT OF THE NEW CCTV INSTALLATIONS ONLY. THE FINAL DESIGN OF THE SYSTEM SHALL BE CARRIED OUT BY NSI GOLD CERTIFIED CONTRACTOR.
- THE SPECIALIST DESIGN CONTRACTOR SHALL PROVIDE THE NECESSARY CERTIFICATION FOR THE DESIGN, INSTALLATION AND COMMISSIONING OF THE NEW SECURITY ALARM SYSTEM.
- ALL SECURITY SYSTEMS TO BE FULLY TESTED AND COMMISSIONED UPON COMPLETION OF WORKS PRIOR TO HANDOVER.
- PLEASE READ IN CONJUNCTION WITH THE SECURITY LAYOUTS.

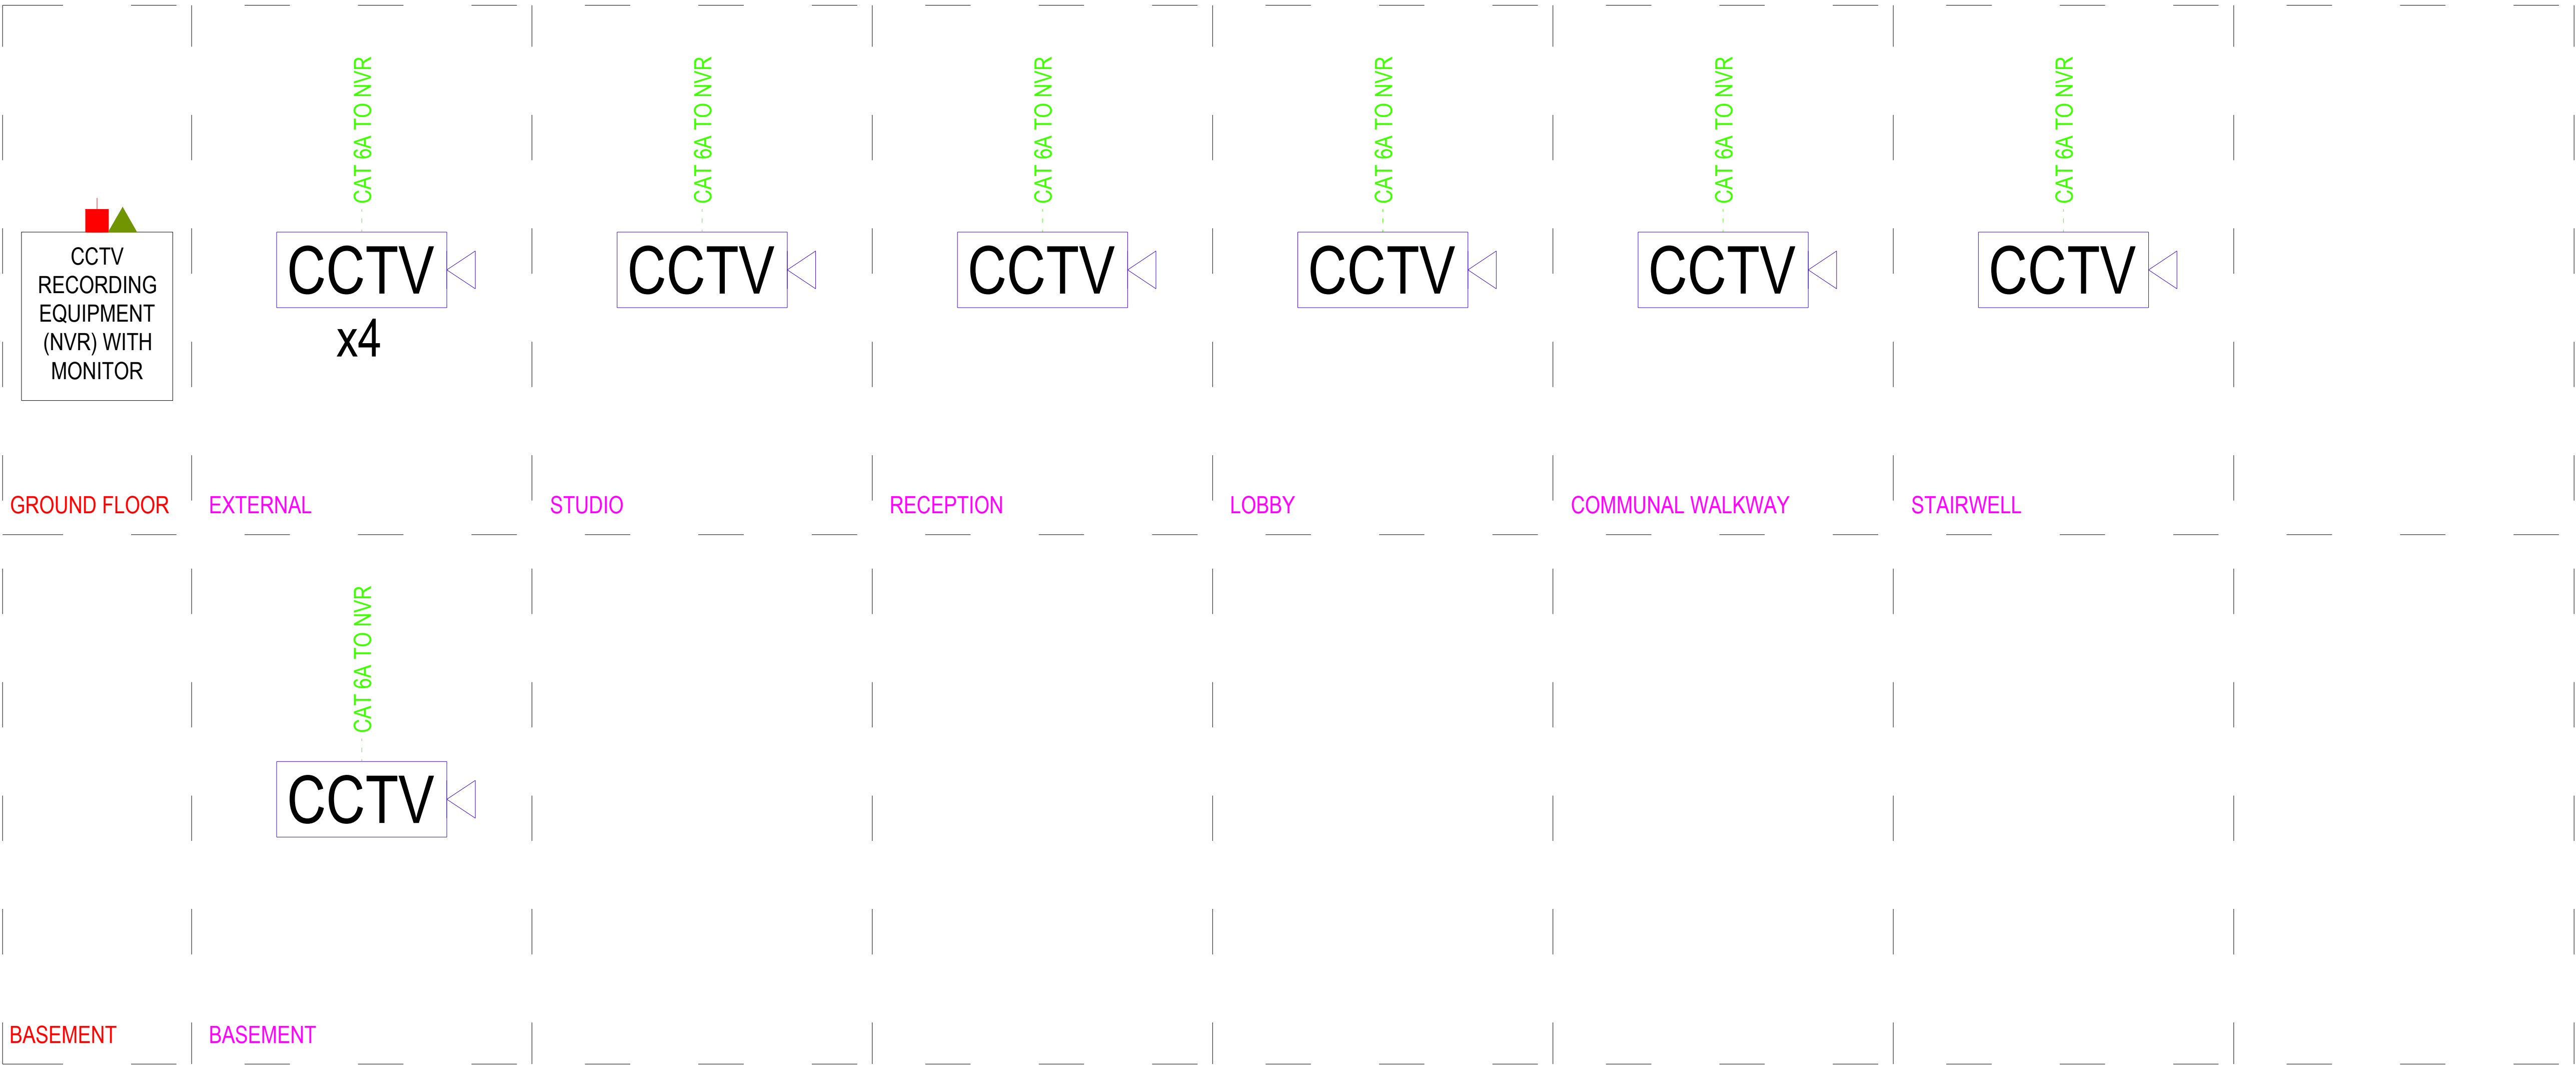

SCHEMATIC REPRESENTATION

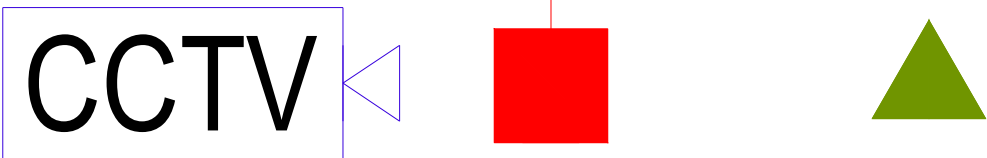

DRAWING REPRESENTATION

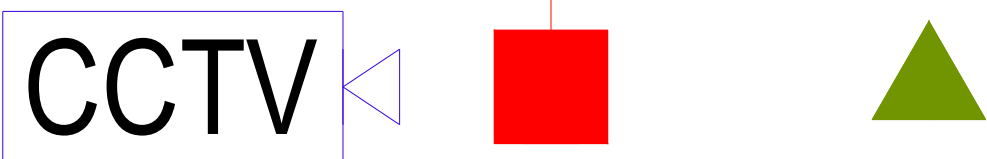

TITLE CCTV CAMERA UNSWITCHED SPUR RJ45 OUTLET

P04	DRAFT TENDER ISSUE	TG	JR	A3	29.10.25
P03	STAGE 4B UPDATE	JG	JR	A3	18.07.25
P02	STAGE 4B ISSUE	JG	JR	A3	13.06.25
P01	STAGE 4A ISSUE	JG	JR	A3	04.04.25
REV	DESCRIPTION	BY	CHK	APP	DATE

Project Status:
DRAFT TENDER ISSUE

h

HARLEY HADDOW

ENGINEERING POWERED BY THE PAST
BUILDING THE FUTURE

Unit A2, Hatchers Yard
9 Tanner Street
London, SE1 3LE
T 44 (0) 203 755 5960
www.harleyhaddow.com

Project: 313293
TOWER OF LONDON
REVELLER

Drawing Title:
CCTV SCHEMATIC

Scale @ A1	Date	Engineer
NTS	APR 2025	JR
Drawing No.	Revision	
313293-HAH-XX-XX-D-E-06891	P04	